
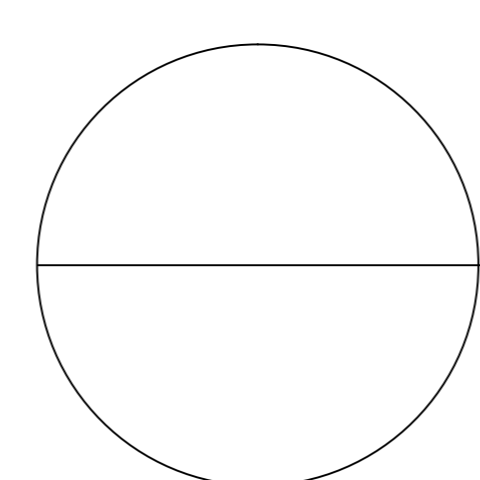



Appendix A

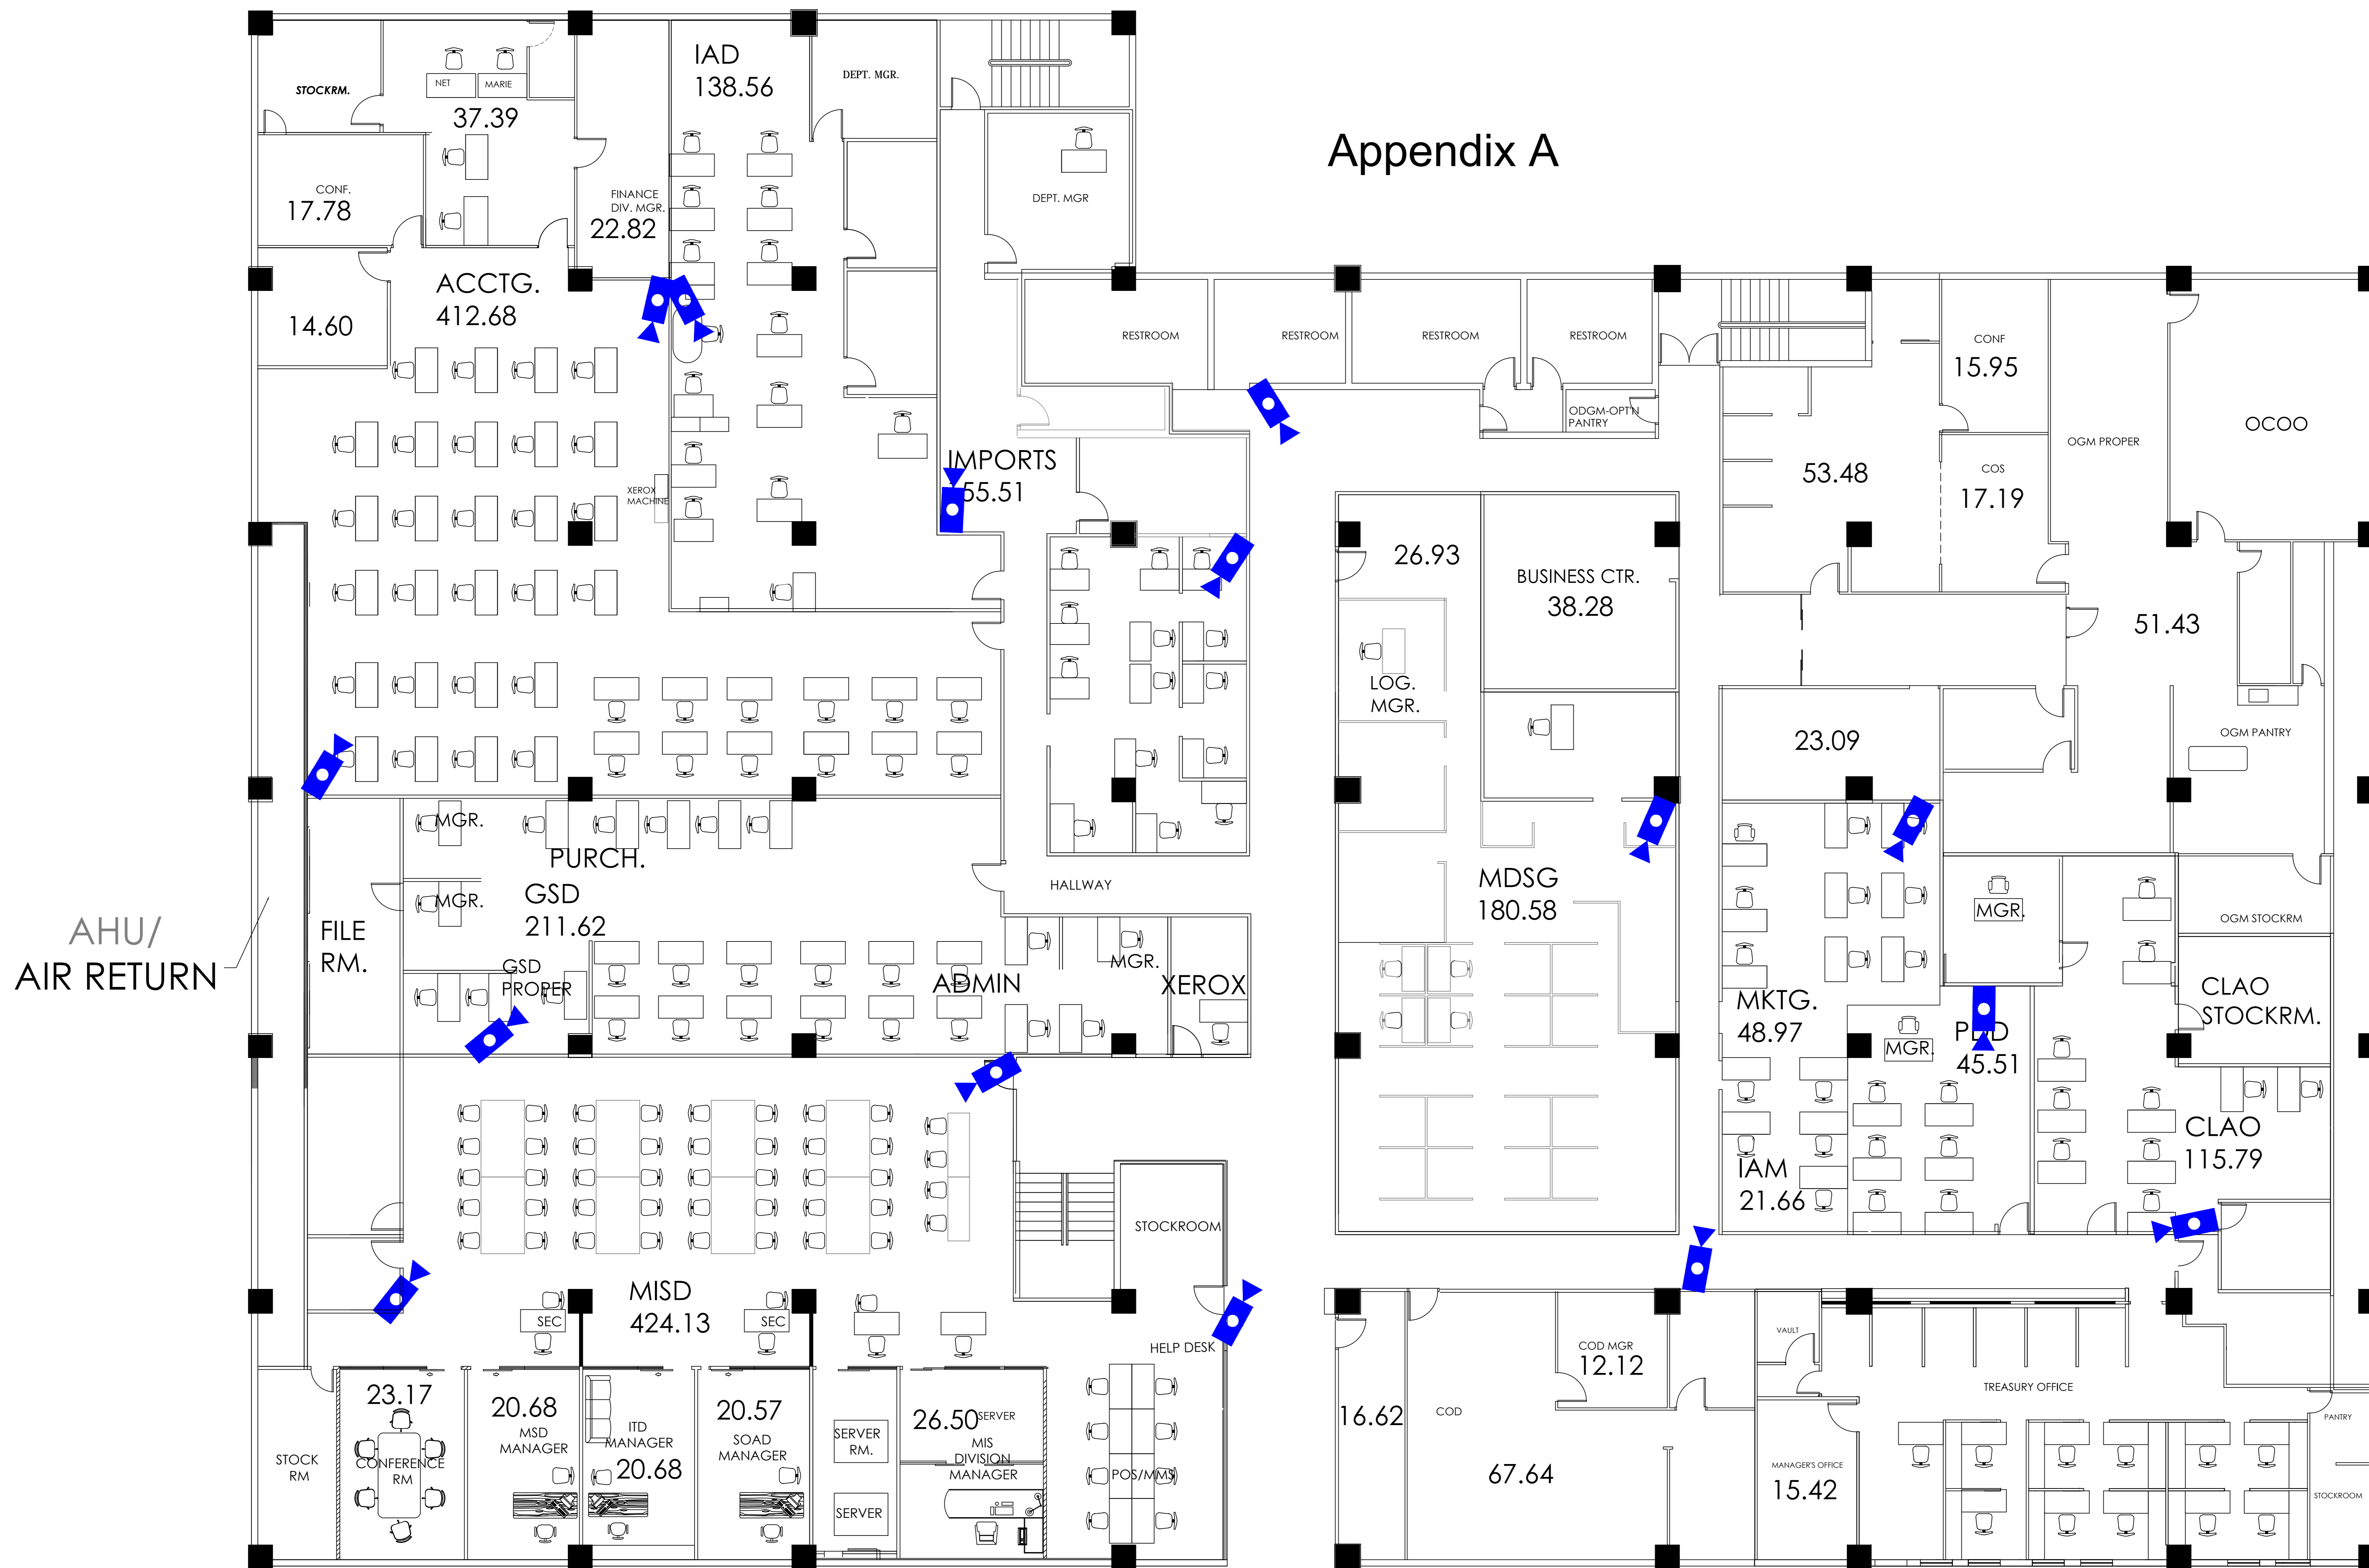

PLAN EHA 2ND FLR.
SCALE NTS

LEGEND:

 - INDOOR CCTV

NAME OF COMPANY:	PROJECT TITLE:	APPROVED BY:	CAD BY: MAE JILYN D. CASTILLO	DATE : JUNE 23, 2022
 DUTY FREE PHILIPPINES EHA BUILDING FIESTAMALL COMPOUND, COLUMBIA COMPLEX NINOY AQUINO AVENUE, PARANAQUE	PROPOSED CCTV LAYOUT AT EHA BUILDING 2ND FLOOR	VICENTE PELAGIO A. ANGALA CHIEF OPERATING OFFICER	CHECKED BY: FRANCISCO S. RAZO JR. NOTED BY: JOSE RONNEL V. DOMINGO PRICLYS S. BACANI	SHEET NO. 1/1